


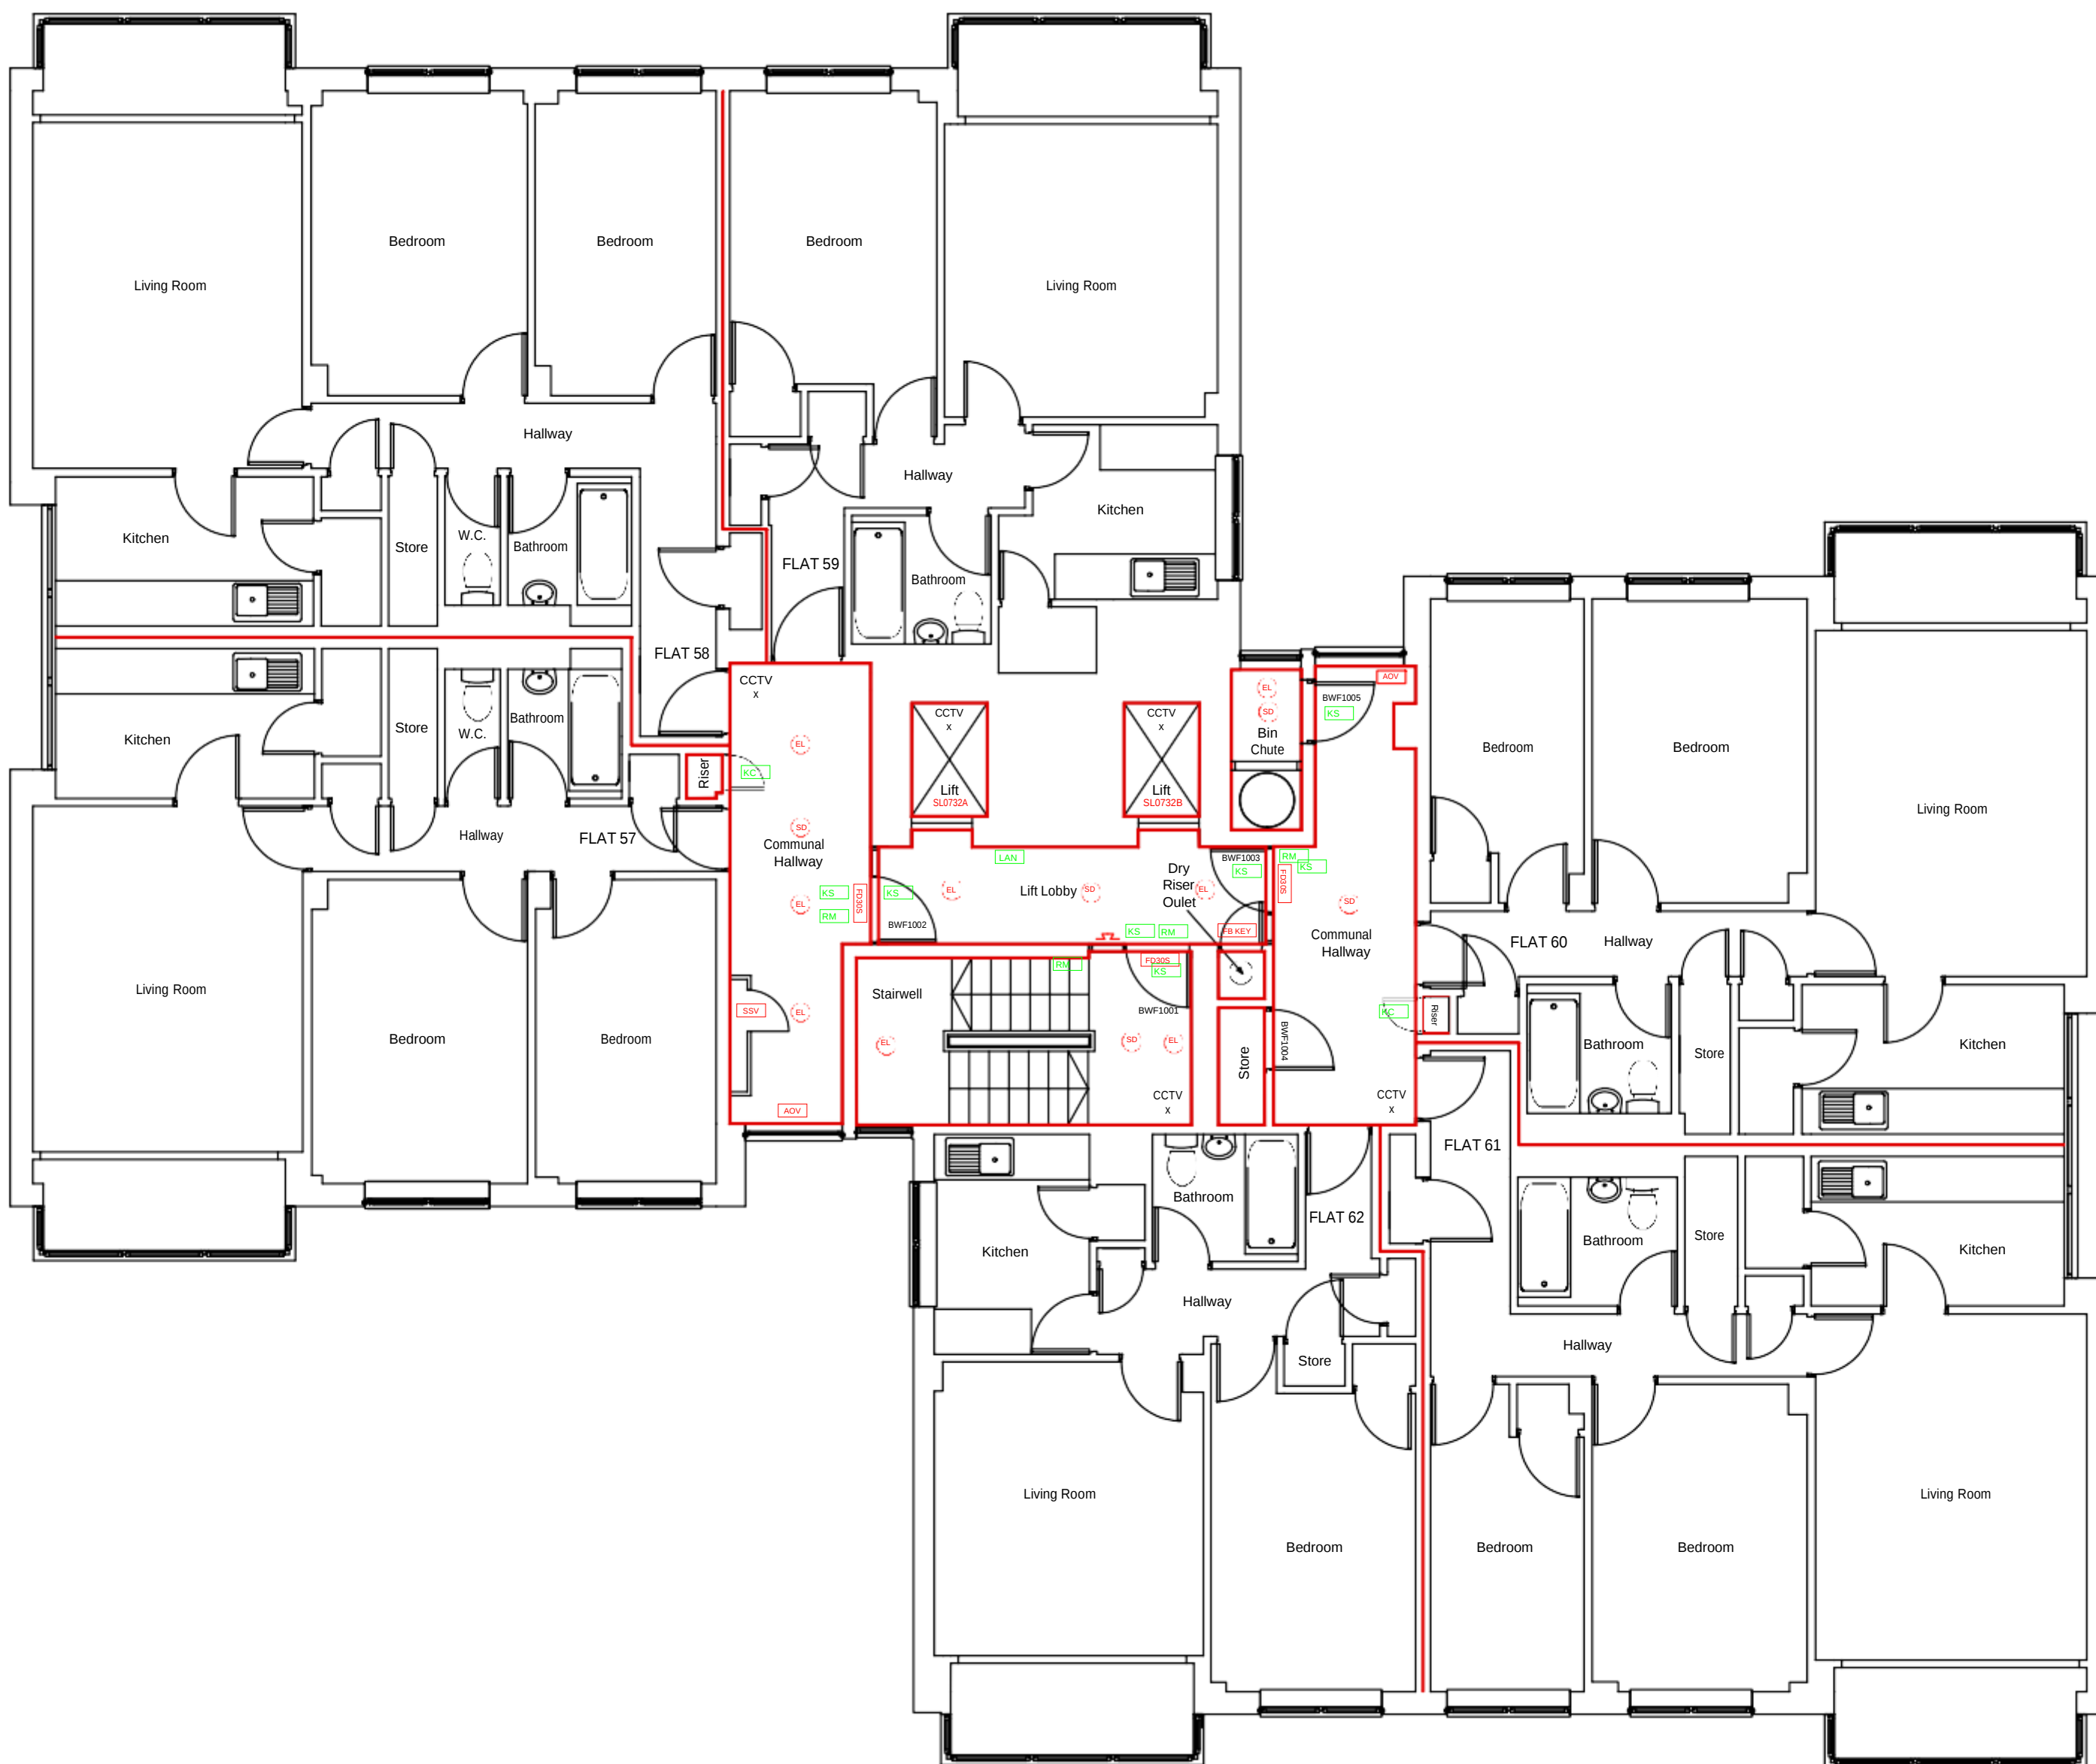

Scale Bar (Metres)

Plans are for illustration purposes only and should not be relied upon for any works carried out or for area calculation or building works.

Key:

FIRE DOOR SIGNS AND FIRE ACTION NOTICES

- | | |
|-----|---|
| FAN | Fire Action Notice |
| KS | "FIRE DOOR KEEP SHUT" sign |
| KL | "FIRE DOOR KEEP LOCKED" sign |
| KC | "AUTOMATIC FIRE DOOR KEEP CLEAR" or
"FIRE EXIT KEEP CLEAR" sign. |
| LAN | "CAUTION, IN THE EVENT OF
FIRE DO NOT USE THIS LIFT" |

FIRE PRECAUTIONS LEGEND

- | | |
|---|---|
|  | Break glass type fire alarm call point. |
|  | Point type heat sensitive detectors. |
|  | Smoke sensitive detectors. |
|  | Smoke detectors in roof space. |
|  | Flashing Strobe indicator. |
|  | Fire alarm indicator / repeat panel. |
|  | Electromagnetic hold open devices |
|  | 20 minute Fire resistant door (FD20). |
|  | Fire resistant flat entrance door. |
|  | Self-closing half-hour fire resisting door. (FD30S). |
|  | Self-closing one hour fire resisting. (FD60S). |
|  | Doors activated by the fire alarm system or in the event of power failure to work as Automatic Opening vent |
|  | Digital electronic lock door entry/exist system |
|  | Door/Access fitted with Gerda H13 Key lock. |
|  | Door/Access fitted with Gerda H36 Key lock. |
|  | Fire alarm sounder. (X indicates integral flashing Xenon light). |
|  | Emergency light point. |
| FIRE EXIT SIGNAGE | |
|  | 'E' Signs to be externally illuminated by emergency light point. |
|  | 'FE' denotes as previous but illuminated as part of sign. |
|  | 'RM' denotes not illuminated sign |
|  | 1.2m x 1.1m fire blankets. |
|  | 6 litres AFFF aqueous foam extinguisher to BS 6575 |
|  | 4.5 litre dry powder type extinguisher. |
|  | 4.5 kg carbon dioxide type extinguisher. |
|  | 9 kg water type extinguisher. |
|  | Firemans Switch |
|  | Emergency Drop Key Access |
| Compartment Walls | |
|  | Smoke Vent control panel |
|  | Permanently Open Vent |
|  | Premises Information Box |
|  | CCTV Security Camera |
|  | Automatic Opening Vent |
|  | AOV Override Switch |
|  | Sprinkler Control Panel |
|  | Firefighters Lift |
|  | Sprinkler Stop Valve |
|  | Sprinkler Point |



Firntec Building Compliance | www.firntec.com | info@firntec.com | 01752 977 147
1st Floor, Endeavour House, 3 Parkway Court, Plymouth, PL6 8LR

Project Address

BROOKWAY COURT
BIDEFORD DRIVE
WYTHENSHAW
M23 0GL

Client:

WYTHENSHAW COMMUNITY HOUSING GROUP

Scale:

1:50 @ A1

Date:

JAN 2023

Drawn by:

NR

Drawing Title:

TENTH FLOOR PLAN

Drawing No:

111 / 01 / 23

Revision

A